



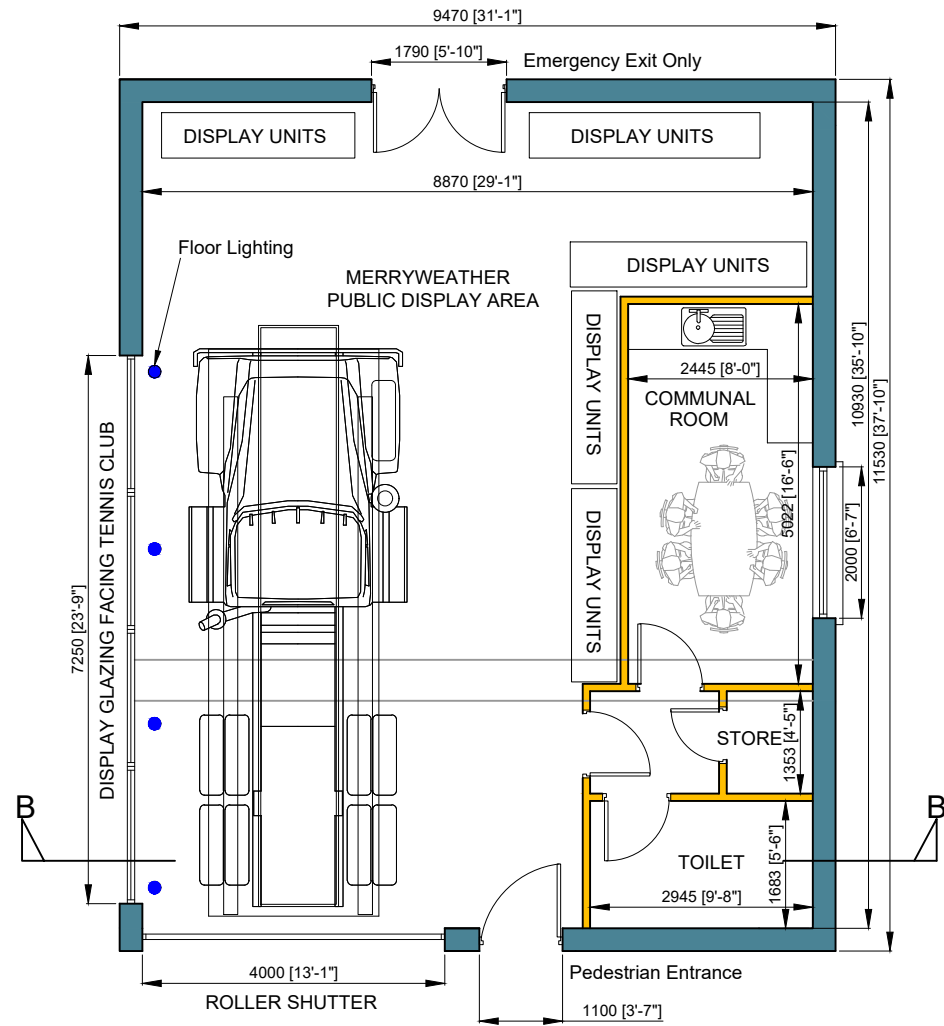


PROPOSED FLOOR PLAN
SCALE 1:100 - 96sqm




CONCEPT DESIGN ONLY

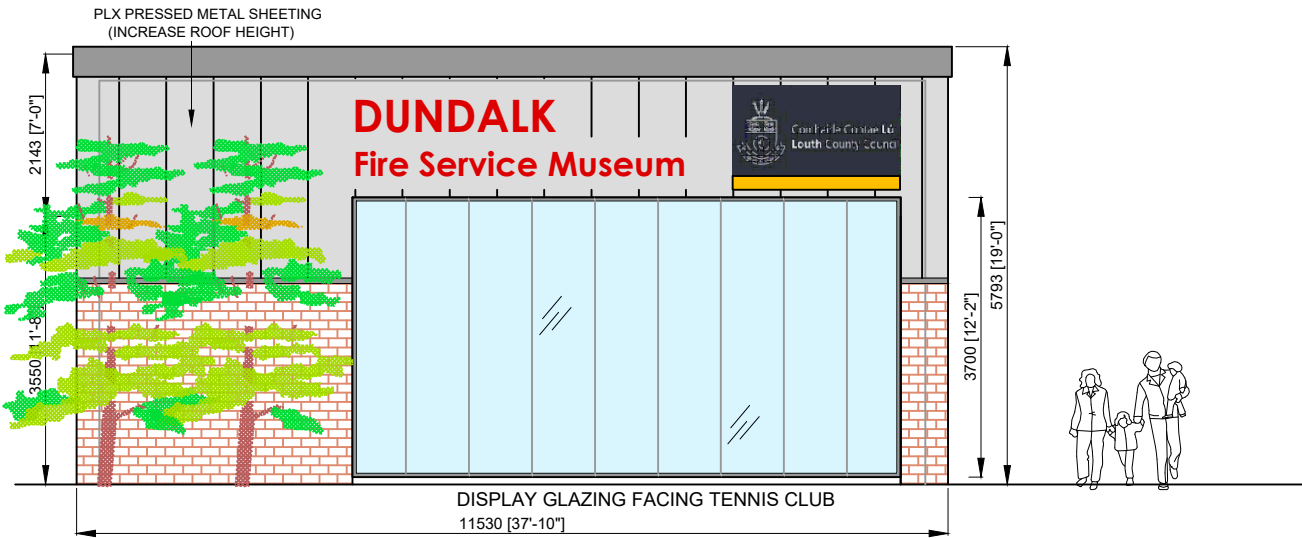


PROPOSED FRONT ELEVATION (North - Facing Tennis Courts / Ramparts)
SCALE 1:100

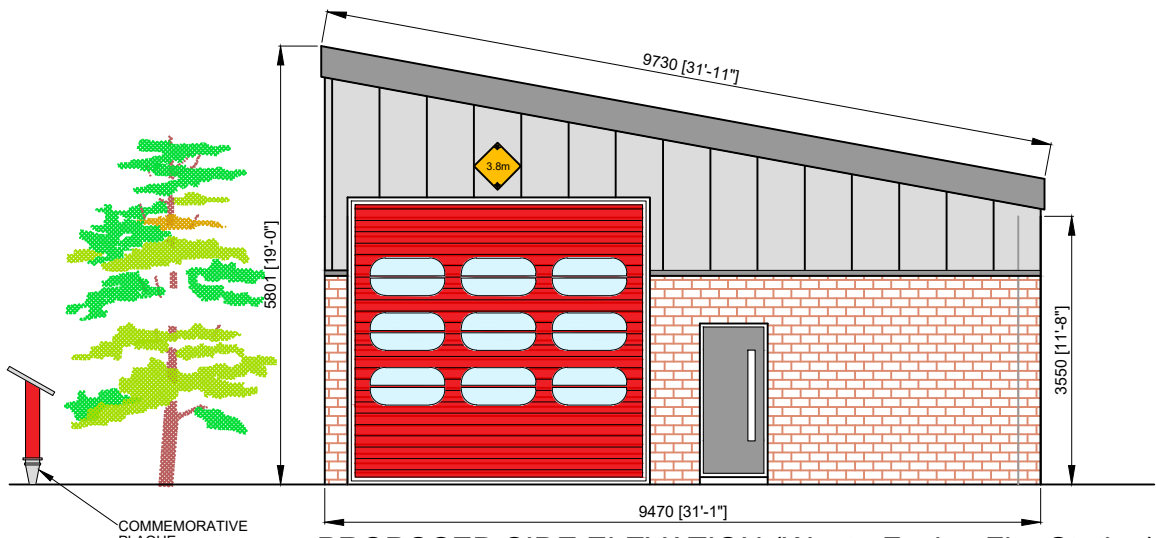


PROPOSED SIDE ELEVATION (West - Facing Fire Station)
SCALE 1:100

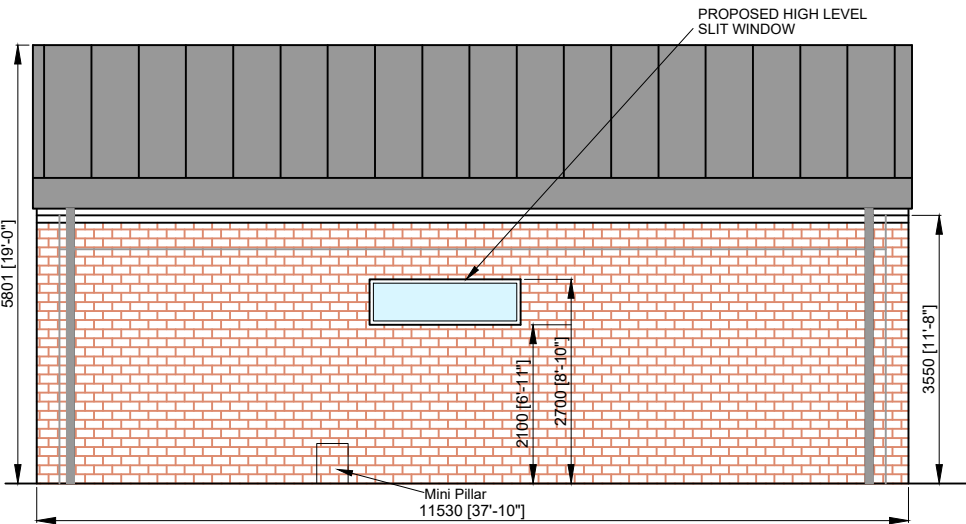

PROPOSED REAR ELEVATION (South - facing green area)
SCALE 1:100

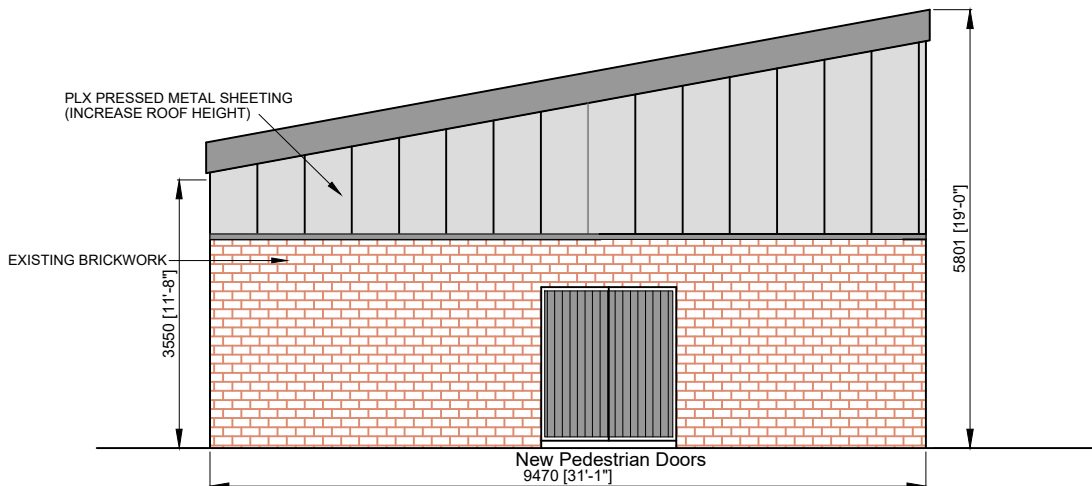

PROPOSED SIDE ELEVATION (East)
SCALE 1:100

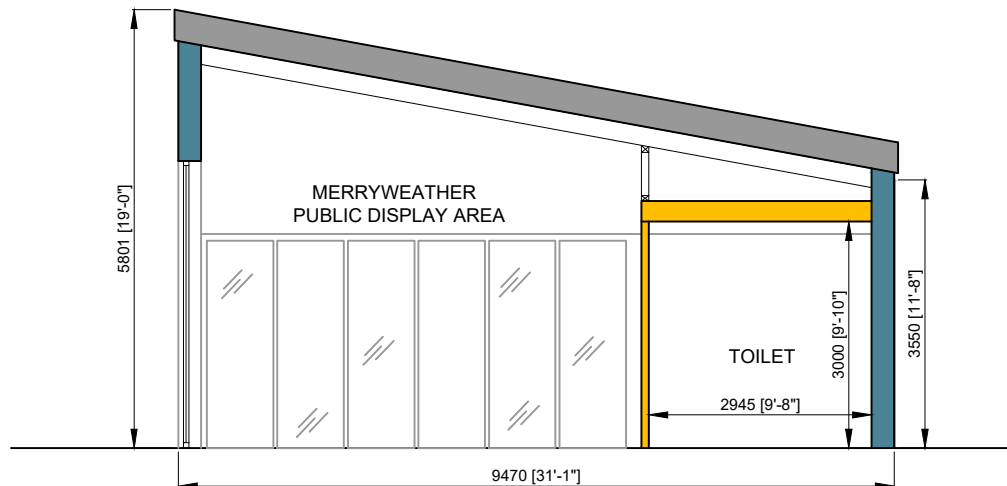

TYPICAL SECTION B-B
SCALE 1:100


MERRYWEATHER FIRE ENGINE



EXAMPLE OF DISPLAY UNITS



NOTES :

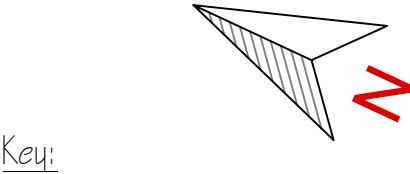

SITE LOCATION OF WORKS
OUTLINED IN RED

c975SQM OR
c.0.97 ACRES

COMHAIRLE CONTAE LÚ
LOUTH COUNTY COUNCIL

MILLENNIUM CENTRE,
SAINT ALPHONSUS ROAD,
DUNDALK,
CO. LOUTH,
A91 KFW6. Phone: +353 42 9335457
Email: info@louthcoco.ie

PROJECT TITLE :
**PART 8 - ALTERATIONS TO EXISTING
PUMPING STATION AT MEADOW
GROVE, DUNDALK, CO LOUTH.**

DRAWING TITLE :
PROPOSED FLOOR PLANS

Scale: 1:100 Sheet size: A2

Drawn by: KM Checked by: CK

OS ref: CYAL50510753

File ref: (N):1 Infra:1 Regen team:DRCD:CDT:02
Projects Delivery:Pumping Station

Date: 30.04.2026

Issued for: PART 8 APPLICATION

Revision: 0.0

Drawing no: LCC-PSMG-DRG-4.0